

Schedule

Symbol	Label	Quantity	Catalog Number	Description	Filename	Lumens Per Lamp	Lumen Multiple r	Light Loss Factor	Wattage	Efficiency
	A	3	SLM-LED-18L-SIL-FT-40-70CRI-IL	CONTACT RYAN ZINSELMEIER-314-531-2600	SLM-LED-18L-SIL-FT-40-70CRI-IL.ies	12046	1	1	148.5	100%
	D	1	SLM-LED-18L-SIL-FT-40-70CRI-IL	CONTACT RYAN ZINSELMEIER-314-531-2600	SLM-LED-18L-SIL-FT-40-70CRI-IL.ies	12046	1	1	297	100%
	C	1	SLM-LED-18L-SIL-FT-40-70CRI-IL	CONTACT RYAN ZINSELMEIER-314-531-2600	SLM-LED-18L-SIL-FT-40-70CRI-IL.ies	12046	1	1	297	100%
	F	1	VL305- WALLMOUNT	CONTACT RYAN ZINSELMEIER-314-531-2600	L85 - VL305.ies	3290	1	1	27.9	100%

Statistics

Description	Symbol	Avg	Max	Avg/Min	Max/Min	Min
Calc Zone #1	+	2.5 fc	8.1 fc	25.0:1	81.0:1	0.1 fc
TRASH ENCLOSURE	+	3.5 fc	4.3 fc	1.8:1	2.3:1	1.9 fc

Note

1. MOUNTING HEIGHT OF 22' (20'POLE)
2. CALCULATIONS TAKEN AT GROUND LEVEL
- 3.CONTACT VILLA LIGHTING- RYAN ZINSELMEIER- RYAN.ZINSELMEIER@VILLALIGHTING.COM- 314-531-2600

SITE LIGHTING FIXTURE SCHEDULE

3

PANDA SITE LIGHTING DESIGN CRITERIA

2


E-106

NO SCALE

E-106

HATCHED AREA INDICATES  
RESTRICTED AREA FOR  
LIGHT STANDARDS

PROPERTY LINE

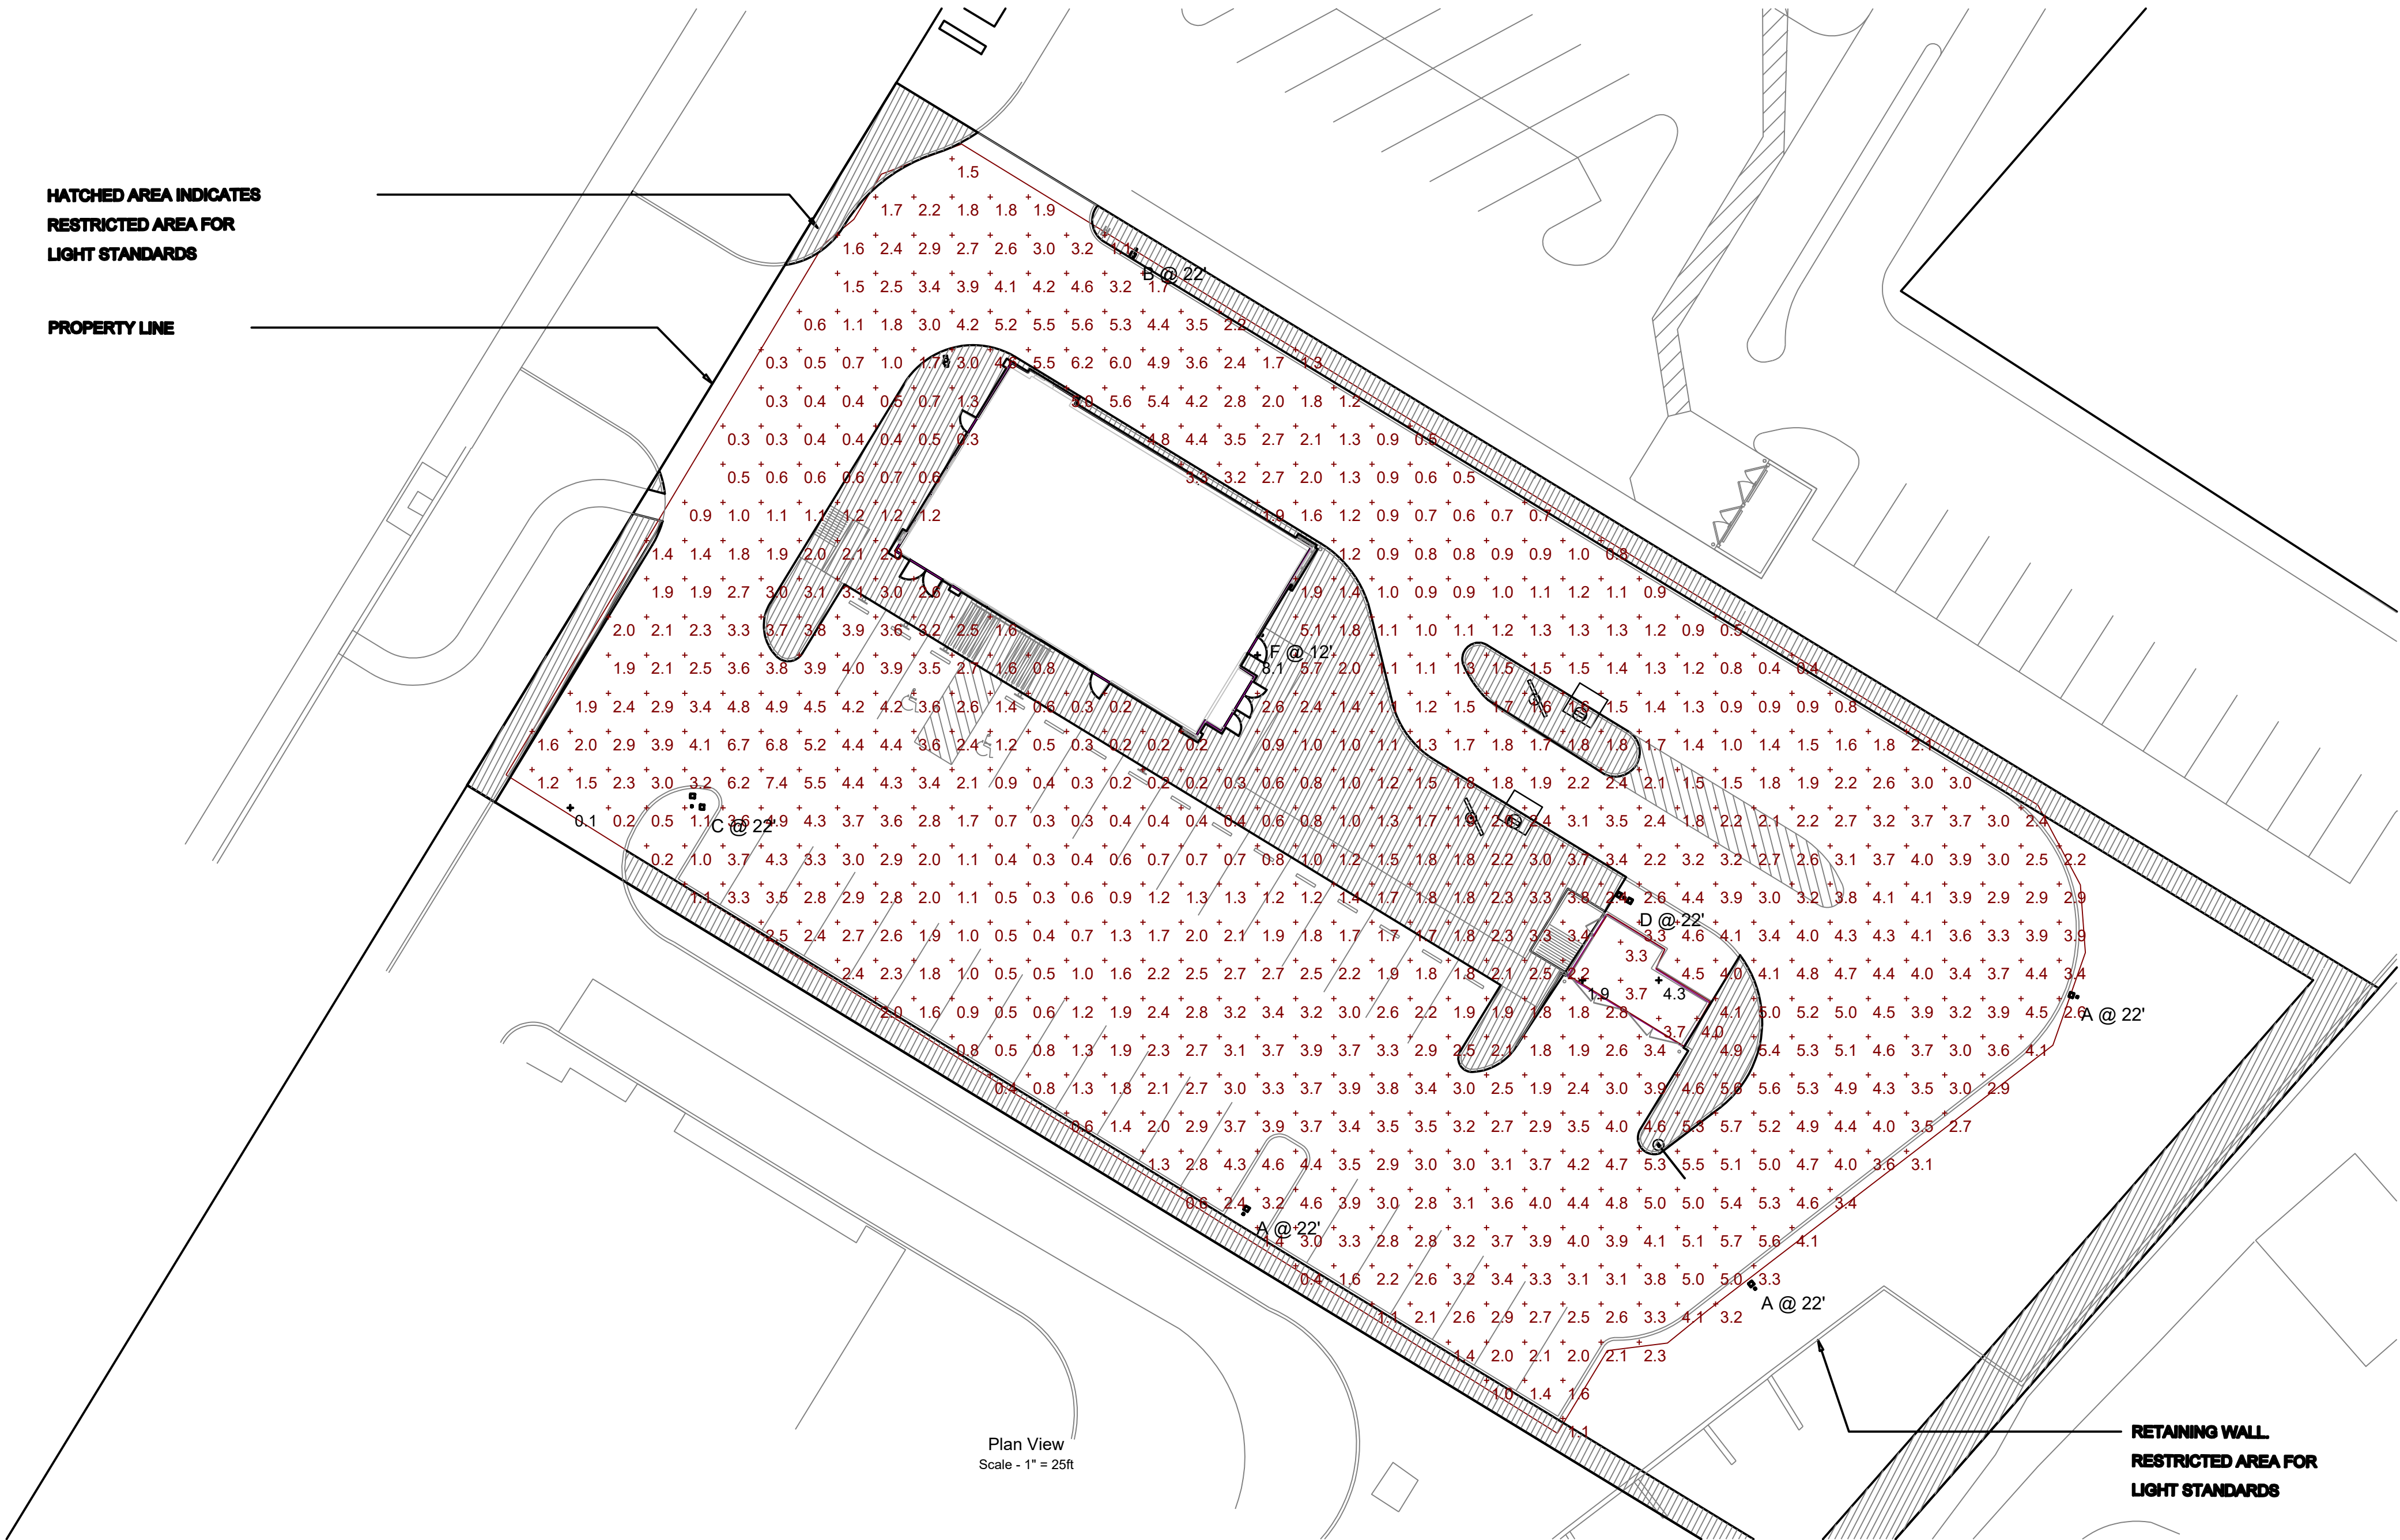

Plan View  
Scale - 1" = 25ft

RETAINING WALL  
RESTRICTED AREA FOR  
LIGHT STANDARDS

SITE PHOTOMETRIC PLAN

1

N.T.S.

E-106



PANDA EXPRESS, INC.  
1683 Walnut Grove Ave.  
Rosemead, California  
91770  
Telephone: 626.799.9898  
Facsimile: 626.372.8288

All ideas, designs, arrangement and plans indicated or represented by this drawing are the property of Panda Express Inc. and were created for use on this specific project. None of these ideas, designs, arrangements or plans may be used by or disclosed to any person, firm, or corporation without the written permission of Panda Express Inc.

REVISIONS:

ISSUE DATE:

ISSUE FOR PERMIT	10-20-22
ISSUE FOR BID	01-30-23

DRAWN BY: AE/SS

PANDA PROJECT #: D23503

PANDA STORE #: -

ARCH PROJECT #: 261-443



MPW ENGINEERING, LLC  
110 W. 7TH STREET • SUITE 600 • TULSA, OK 74109  
(918) 582-4088 • (918) 582-4087 FAX



PANDA EXPRESS

PANDA HOME 2600  
NORTH RIVERSIDE DR & 2ND ST.  
CLARKSVILLE, TN 37040

E-106

HOT - MEDIUM  
SITE PHOTOMETRIC PLAN

PANDA HOME 2600 R4